

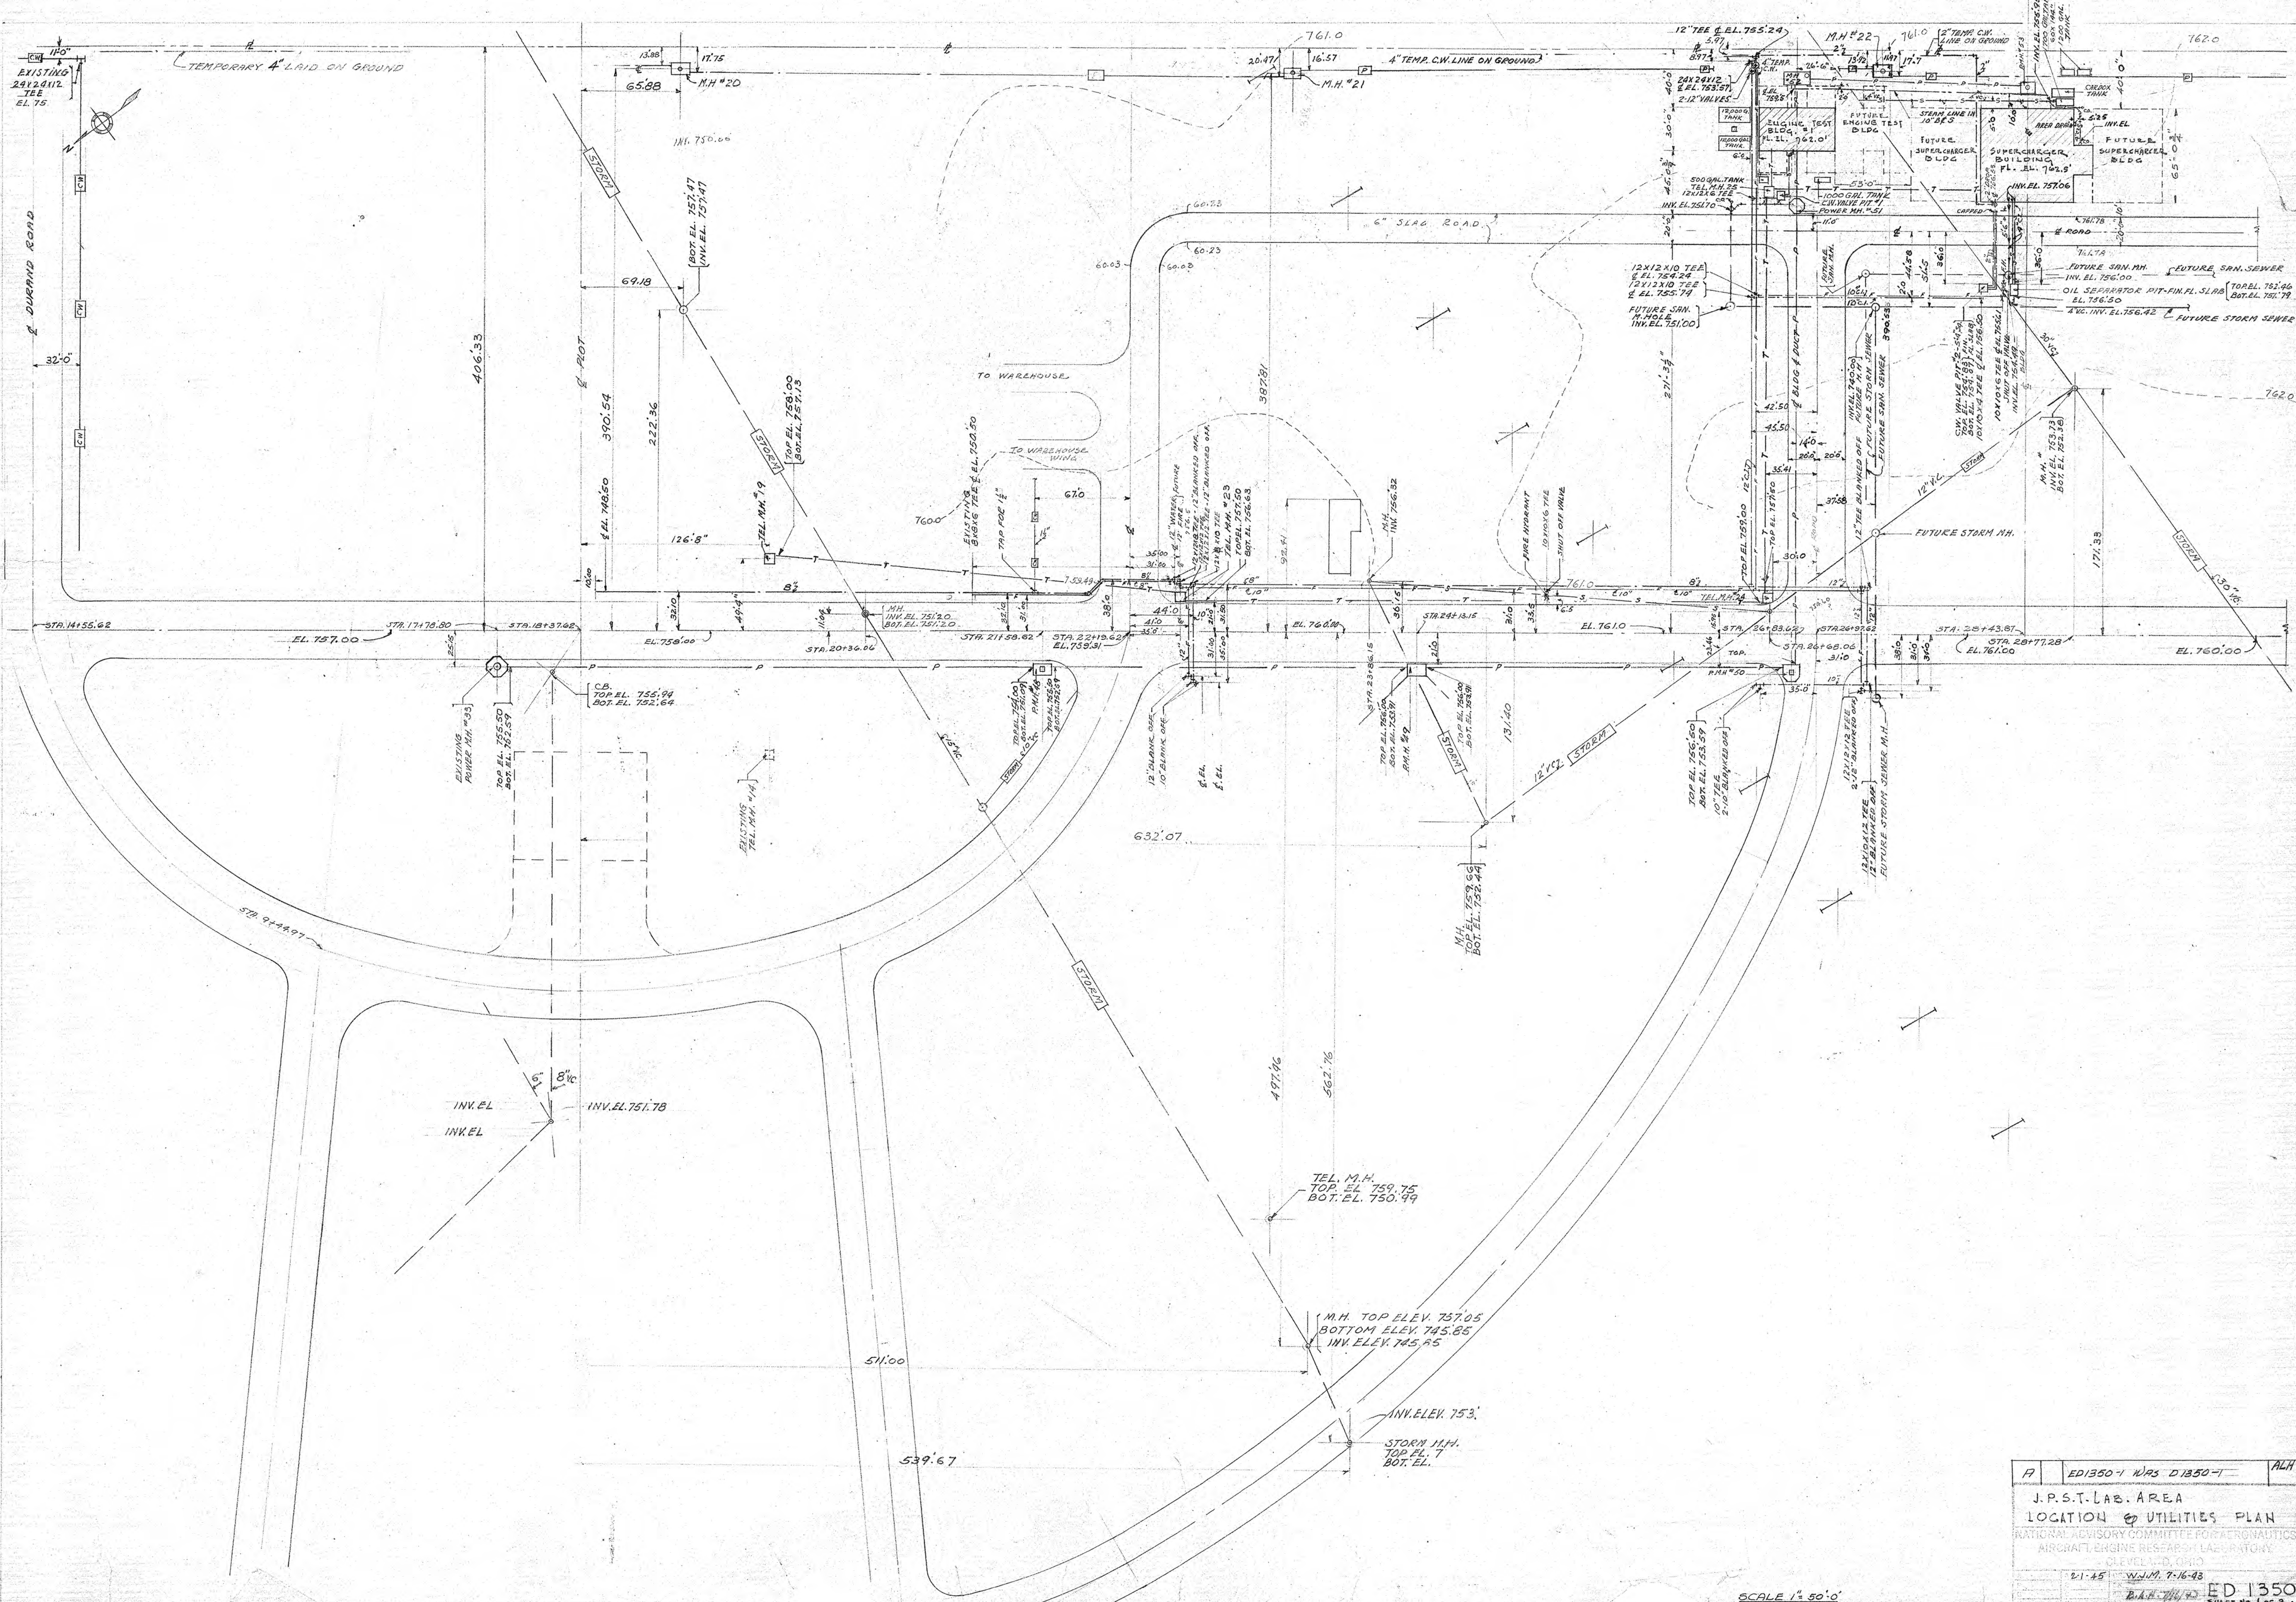


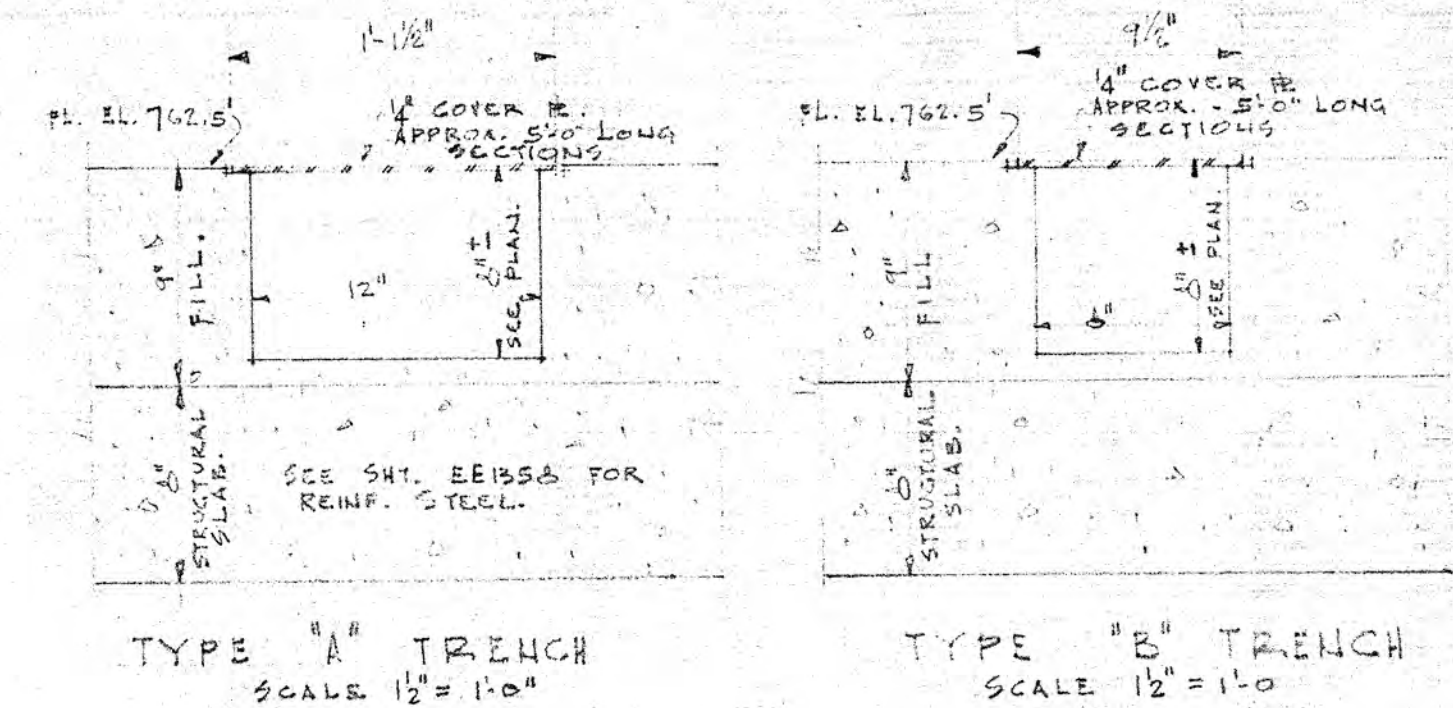

ED 1350-1	NRS D 1350-1	ALH
J.P.S.T. LAB. AREA		
LOCATION & UTILITIES PLAN		
NATIONAL ADVISORY COMMITTEE FOR AERONAUTICS		
AIRCRAFT ENGINE RESEARCH LABORATORY		
CLEVELAND, OHIO		
21-45	W.J.M. 7-16-48	ED 1350
SHEET NO. 1 OF 3		

SCALE 1" = 50'-0"

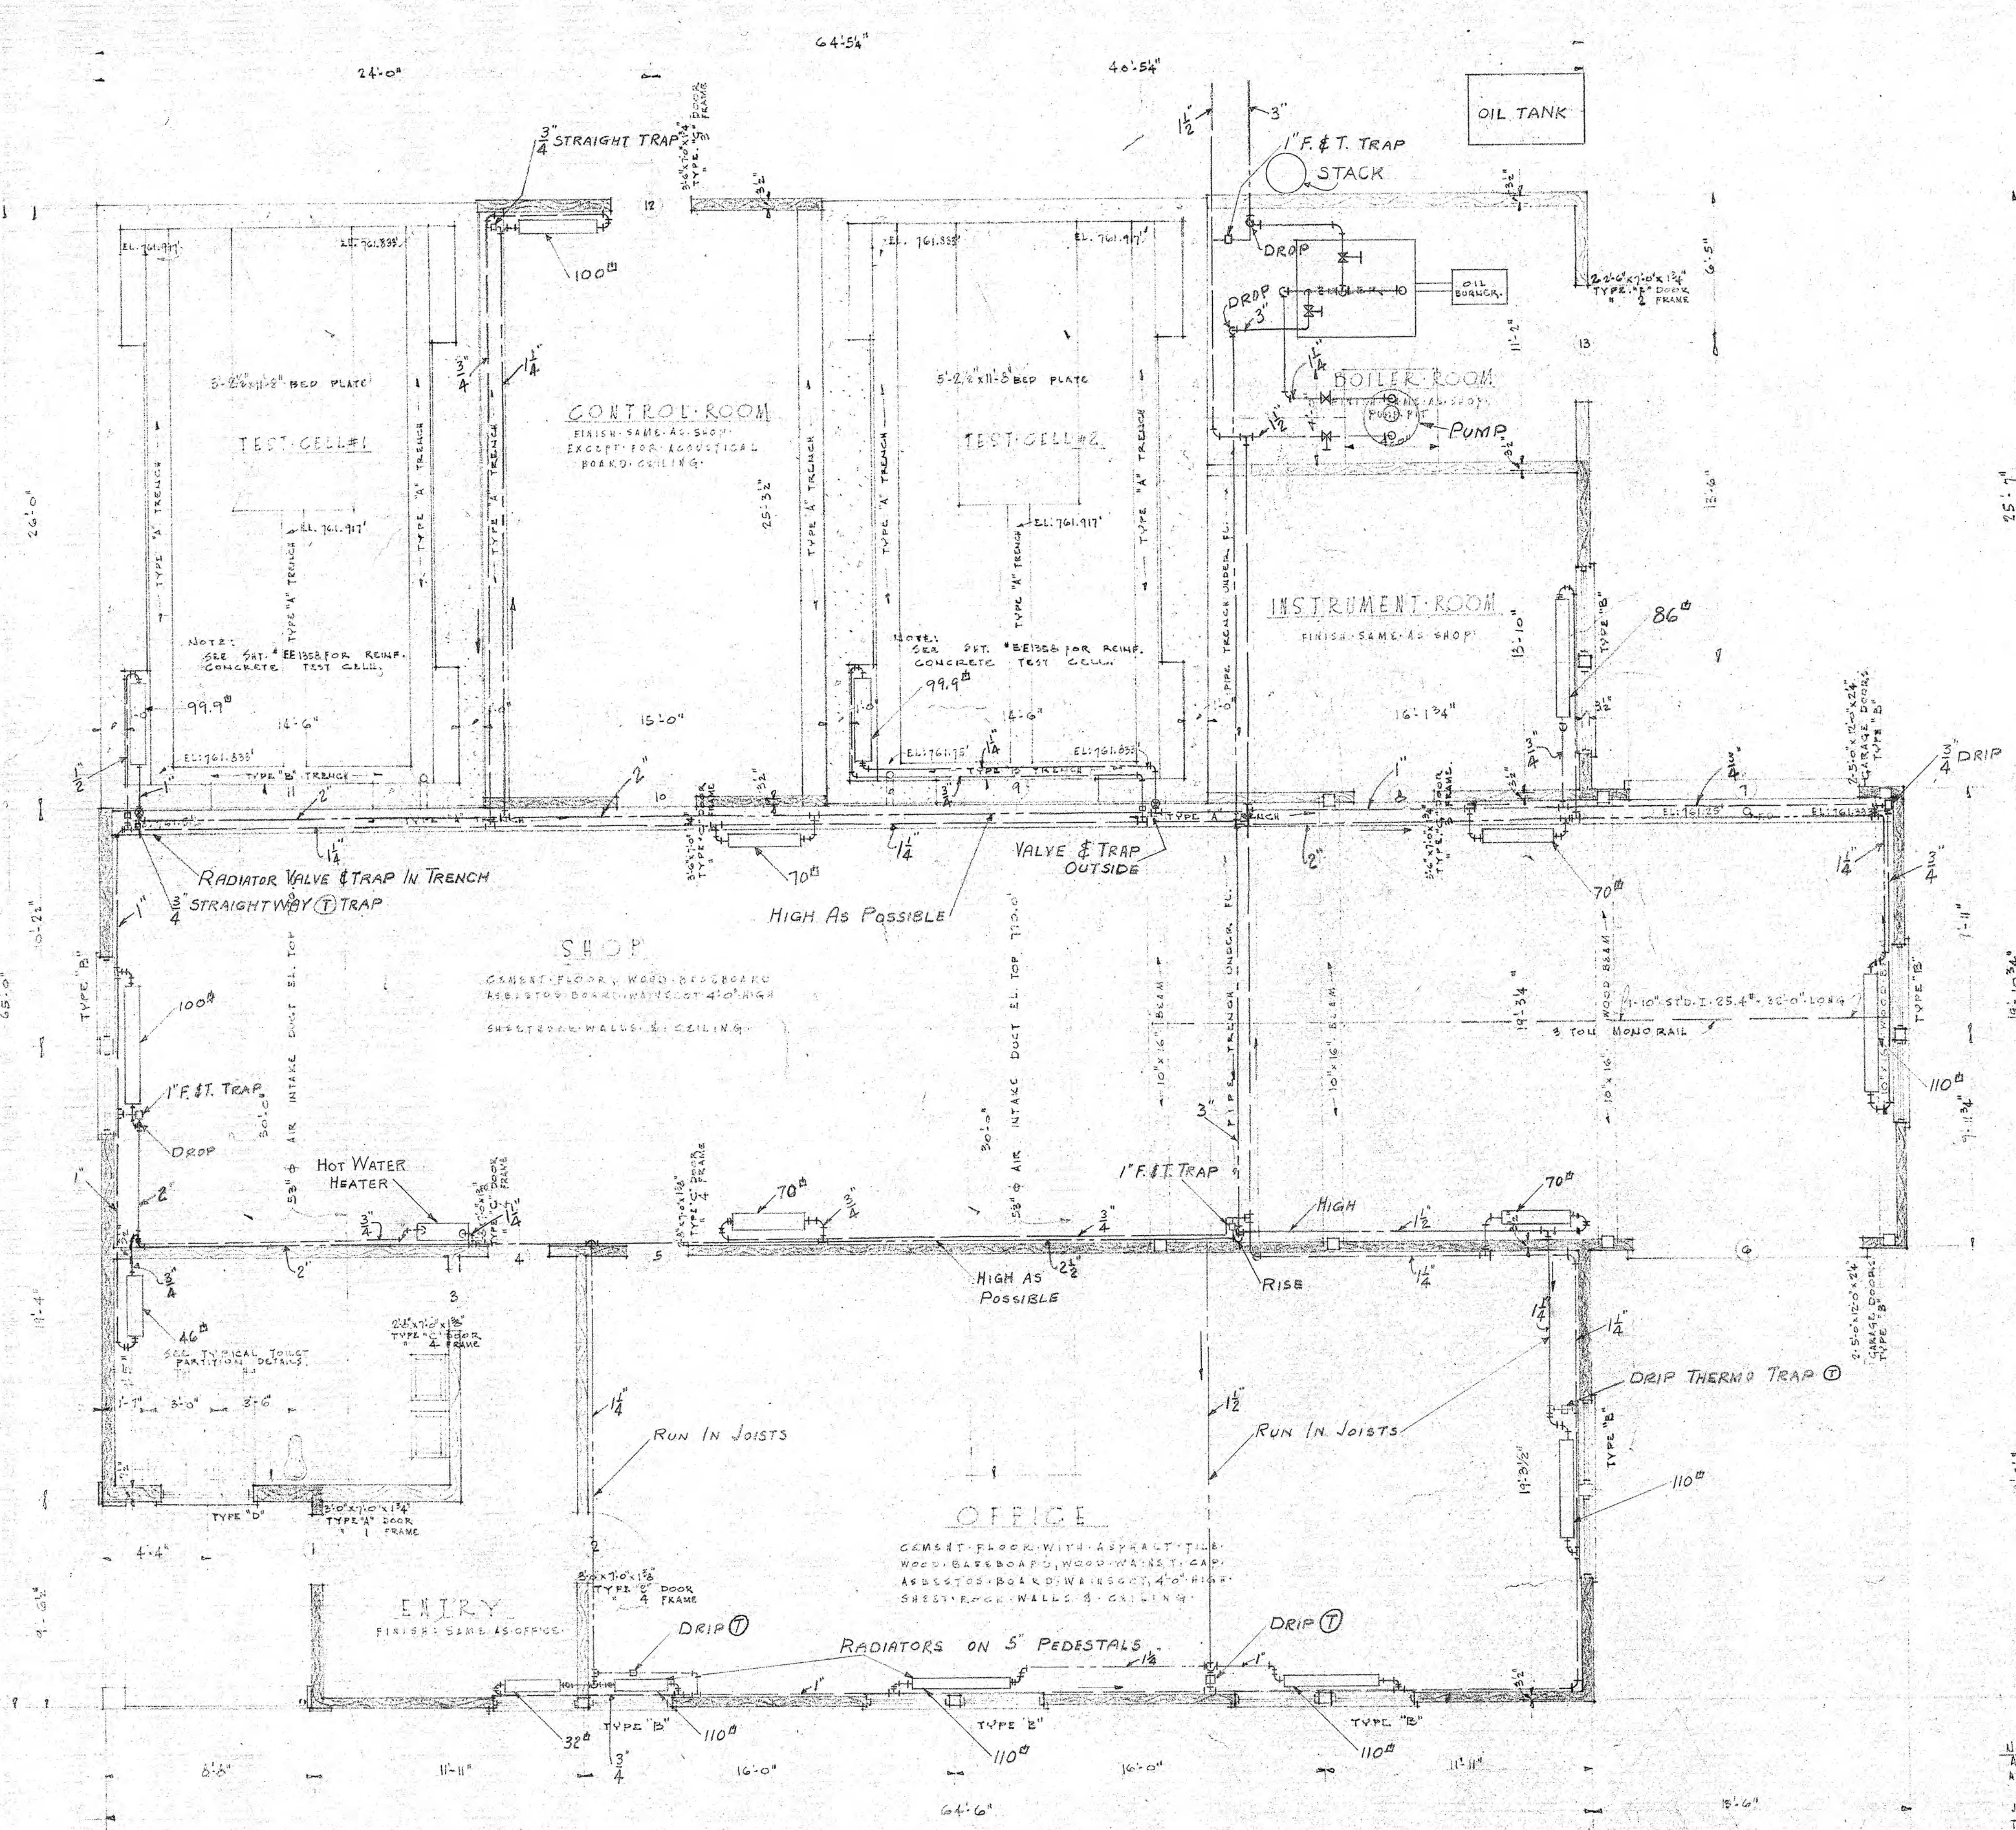

FLOOR PLAN
SCALE 1/4" = 1'-0"

NOTE:
ALL WOOD PARTITIONS & WALLS
ARE DIMENSIONED TO FACE OF STUDS
BACK WOOD BETWEEN ROOF
JOISTS IN ALL ROOMS EXCEPT
TEST CELLS #1 & #2 AND
BOILER ROOM.

LEGEND:
INDICATES BATT
WOOL INSULATION

1352-2


A ED 1352-2 HAS D 1352-2 ALH

HEATING PLAN


SUPERCHARGER BLDG 101

FLOOR PLAN


A-2-1-45 WEG. 5-4-43 LWR 9-4-43 ED 1352-2

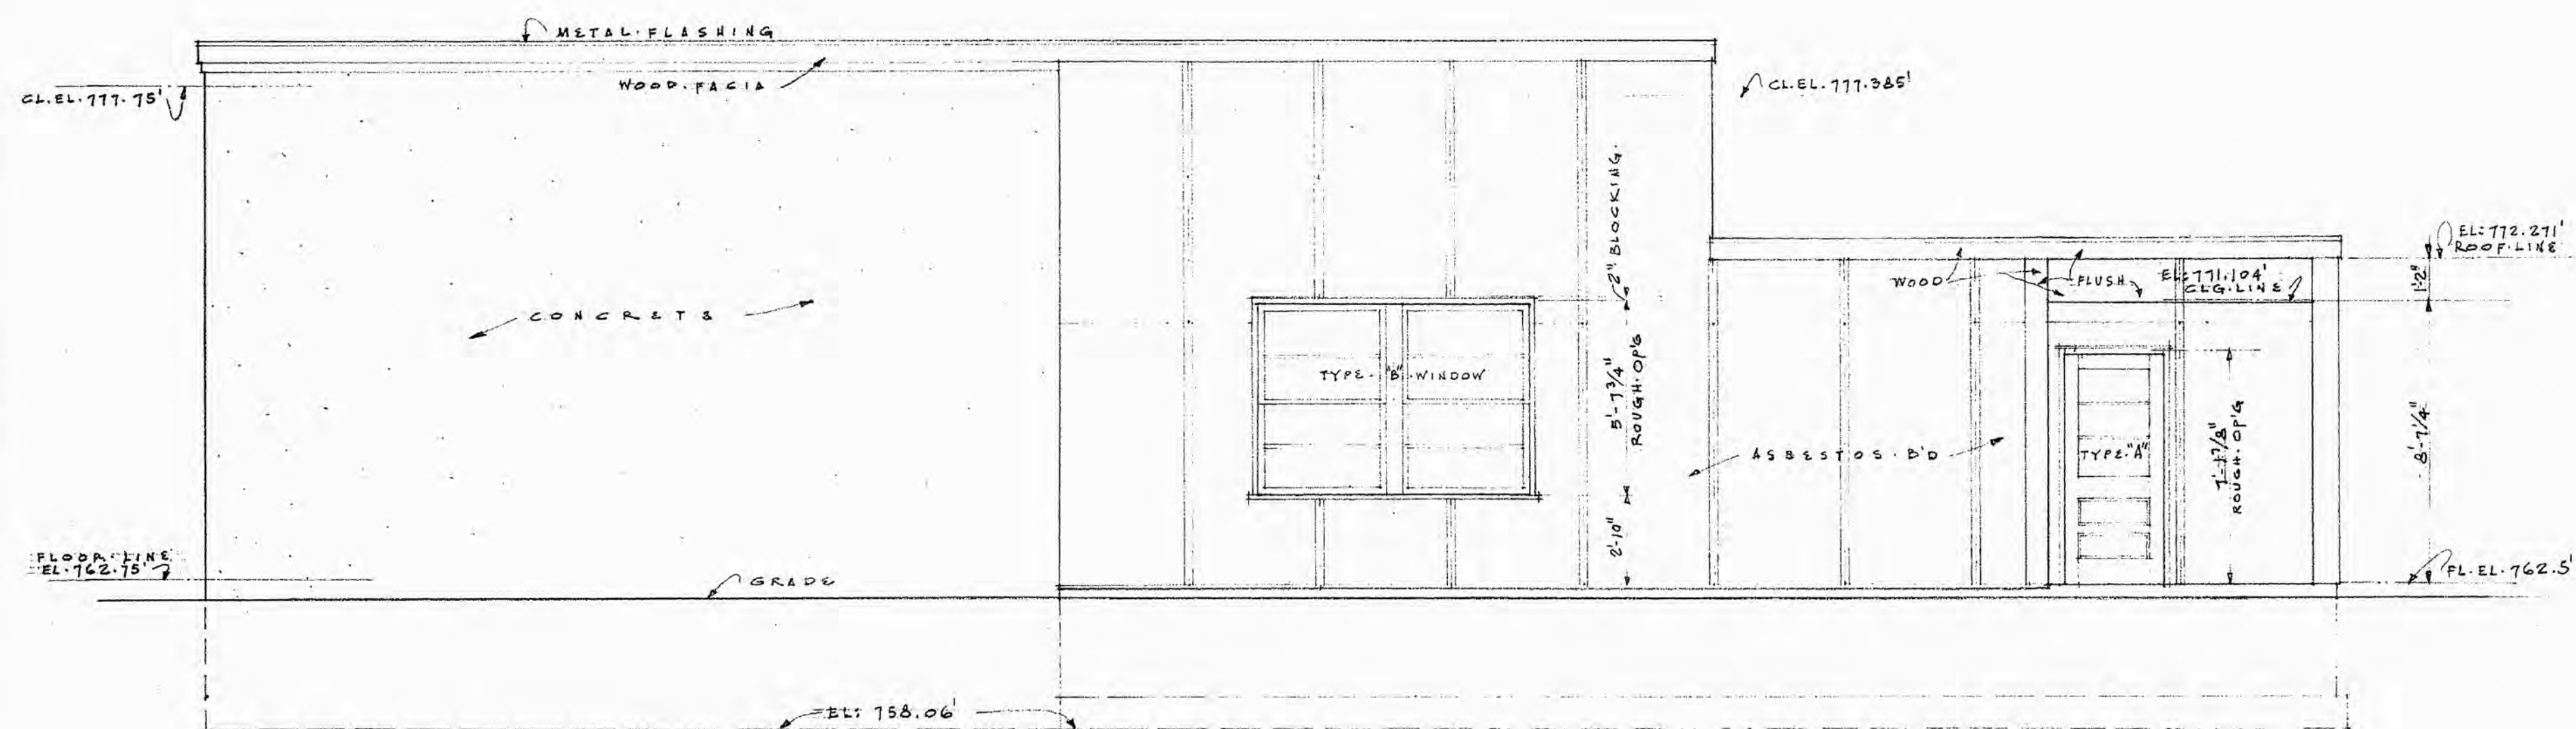

NORTH-ELEVATION
SCALE: 1/4" = 1'-0"

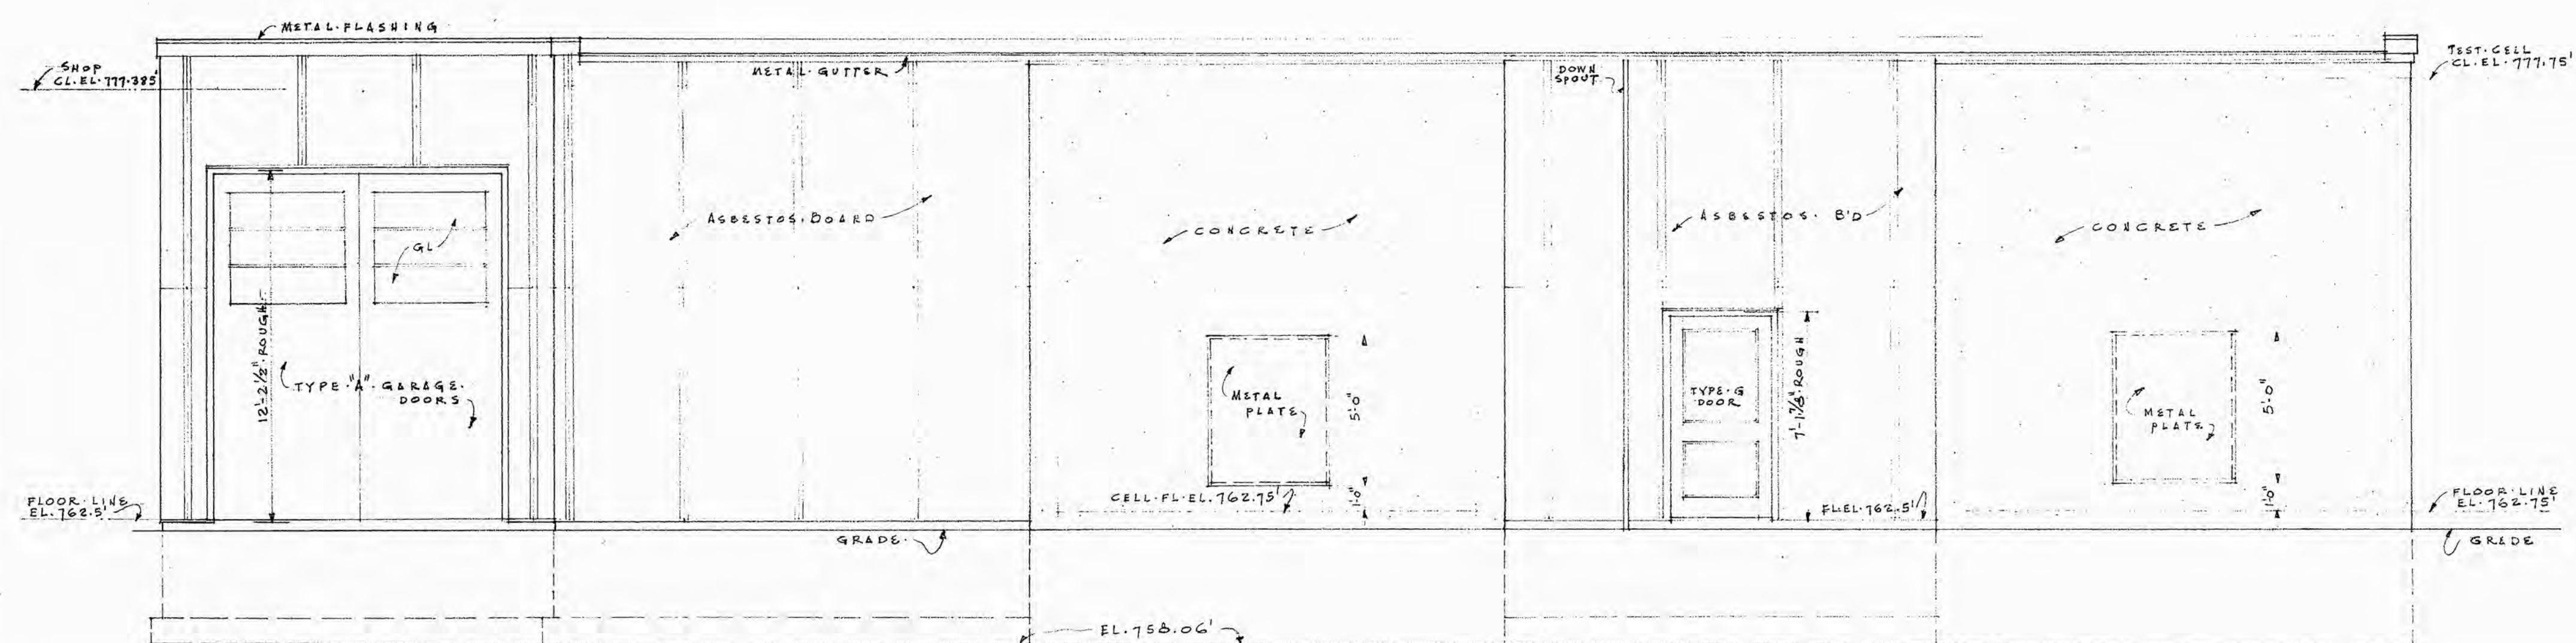


EAST-ELEVATION
SCALE: 1/4" = 1'-0"

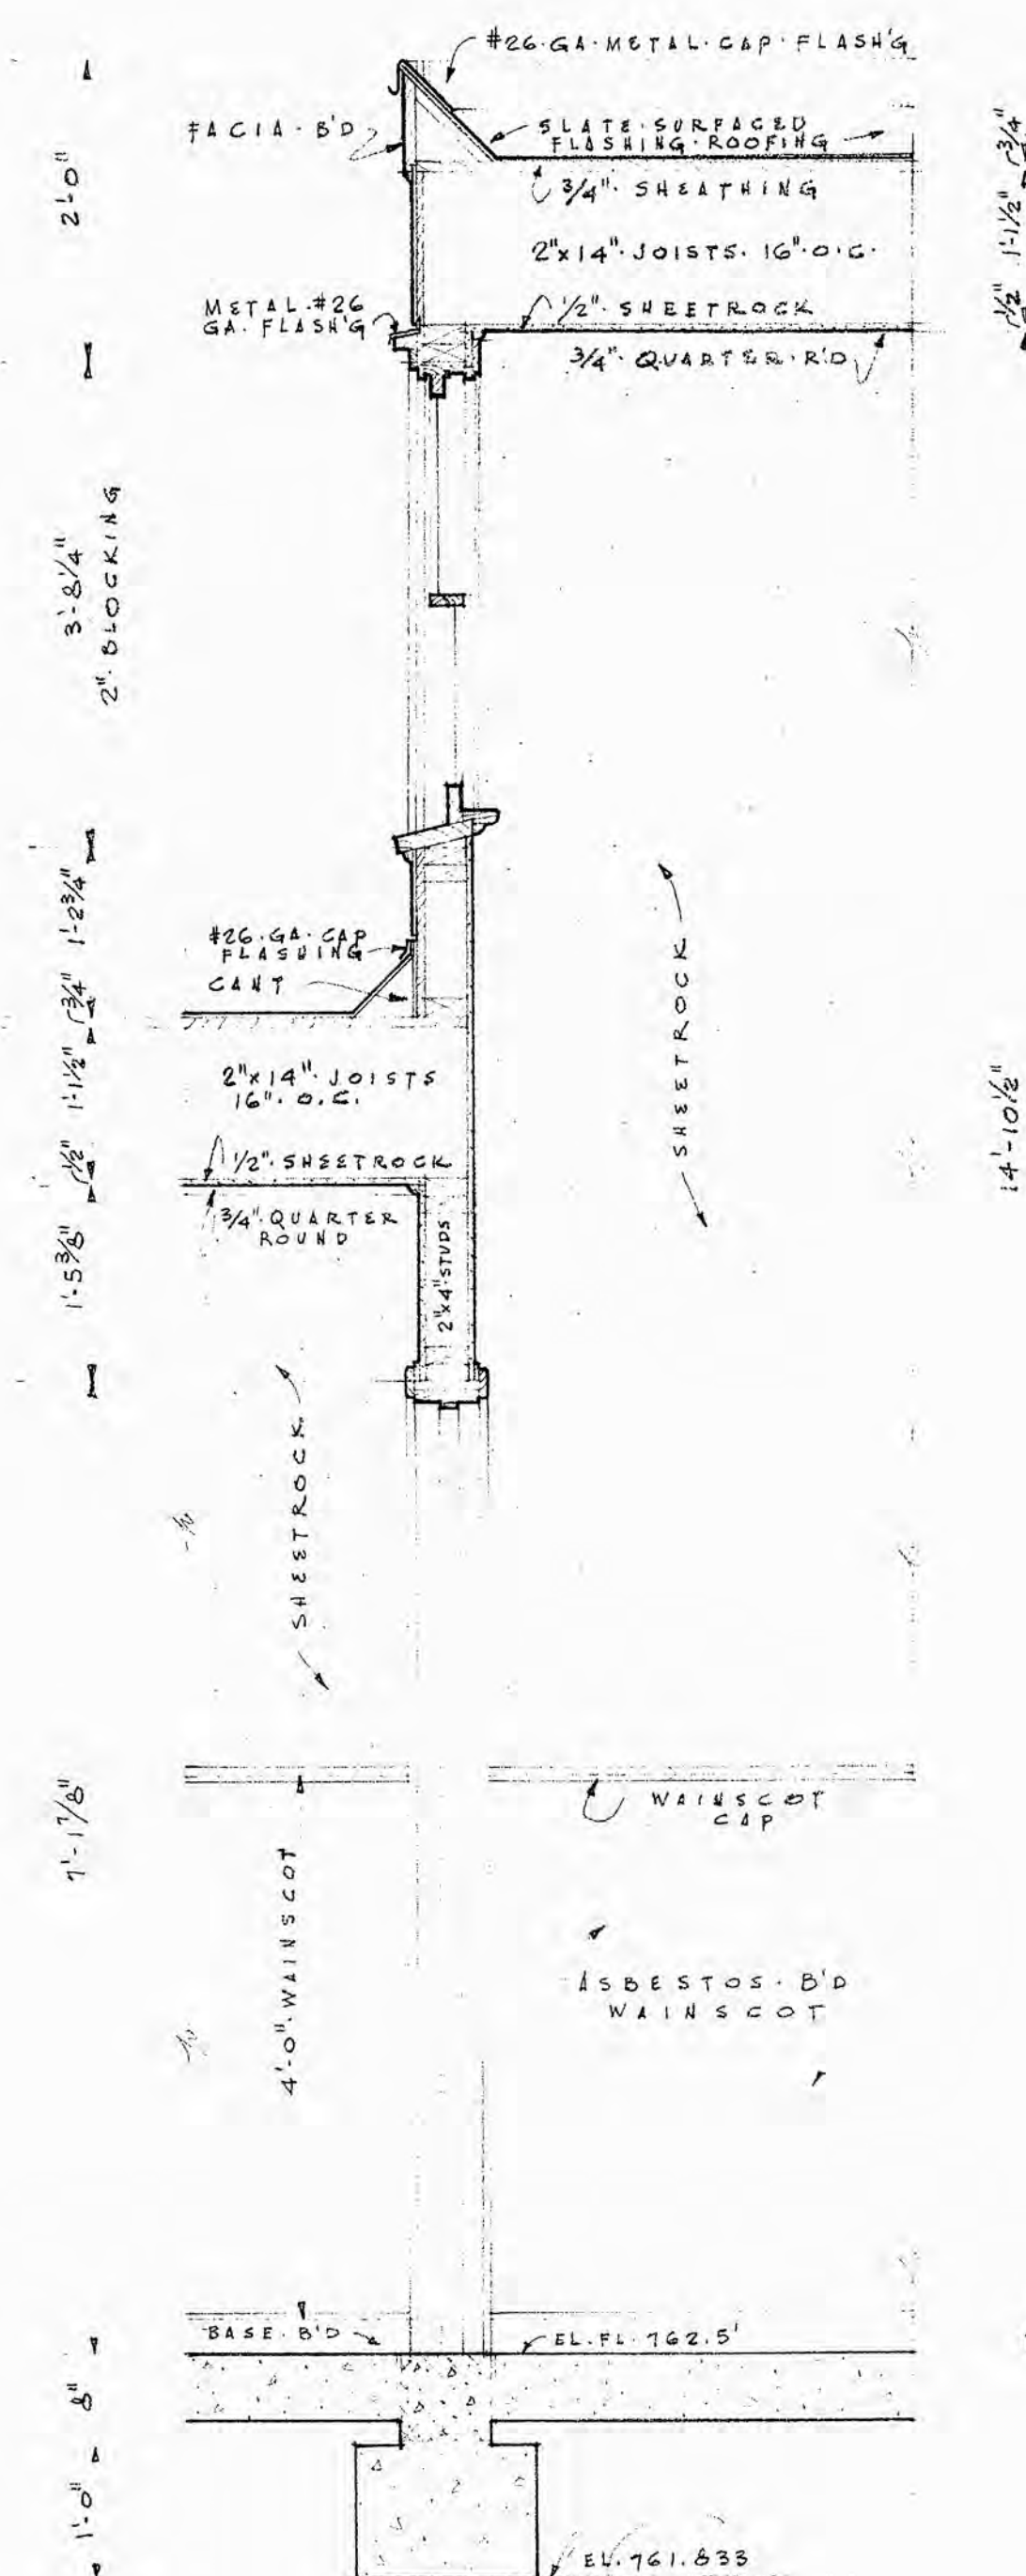


SECTION-OF-WALL
BETWEEN-OFFICE- & SHOP
SCALE: 3/4" = 1'-0"


SUPERCHARGER BUILD'G	
ELEVATIONS & WALL SECTION	
NATIONAL BUREAU OF STANDARDS	
BUREAU OF BUILDING RESEARCH	
WASHINGTON, D.C.	
ED 1354-1	

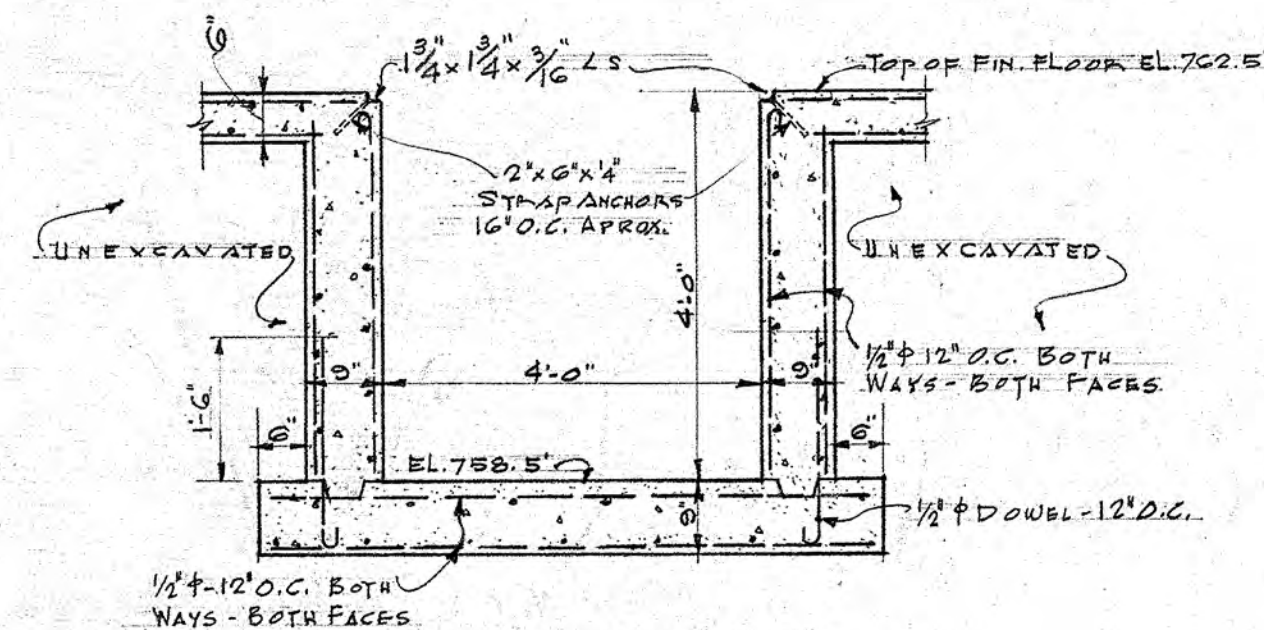


SECTION E-E
SCALE 1/2" = 1'-0"

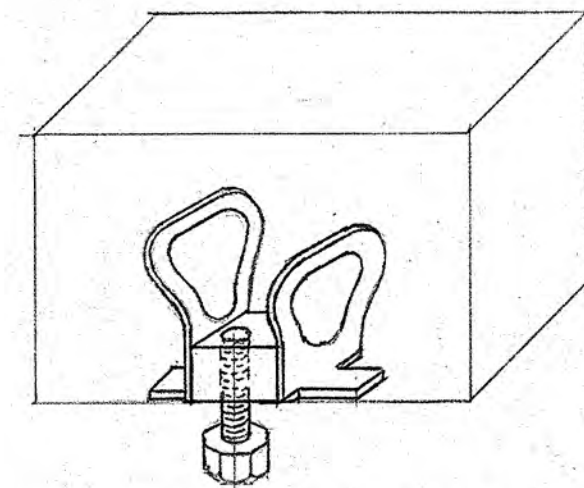


TYPICAL SECTION
SHOWING SCREW
TYPE INSERTS

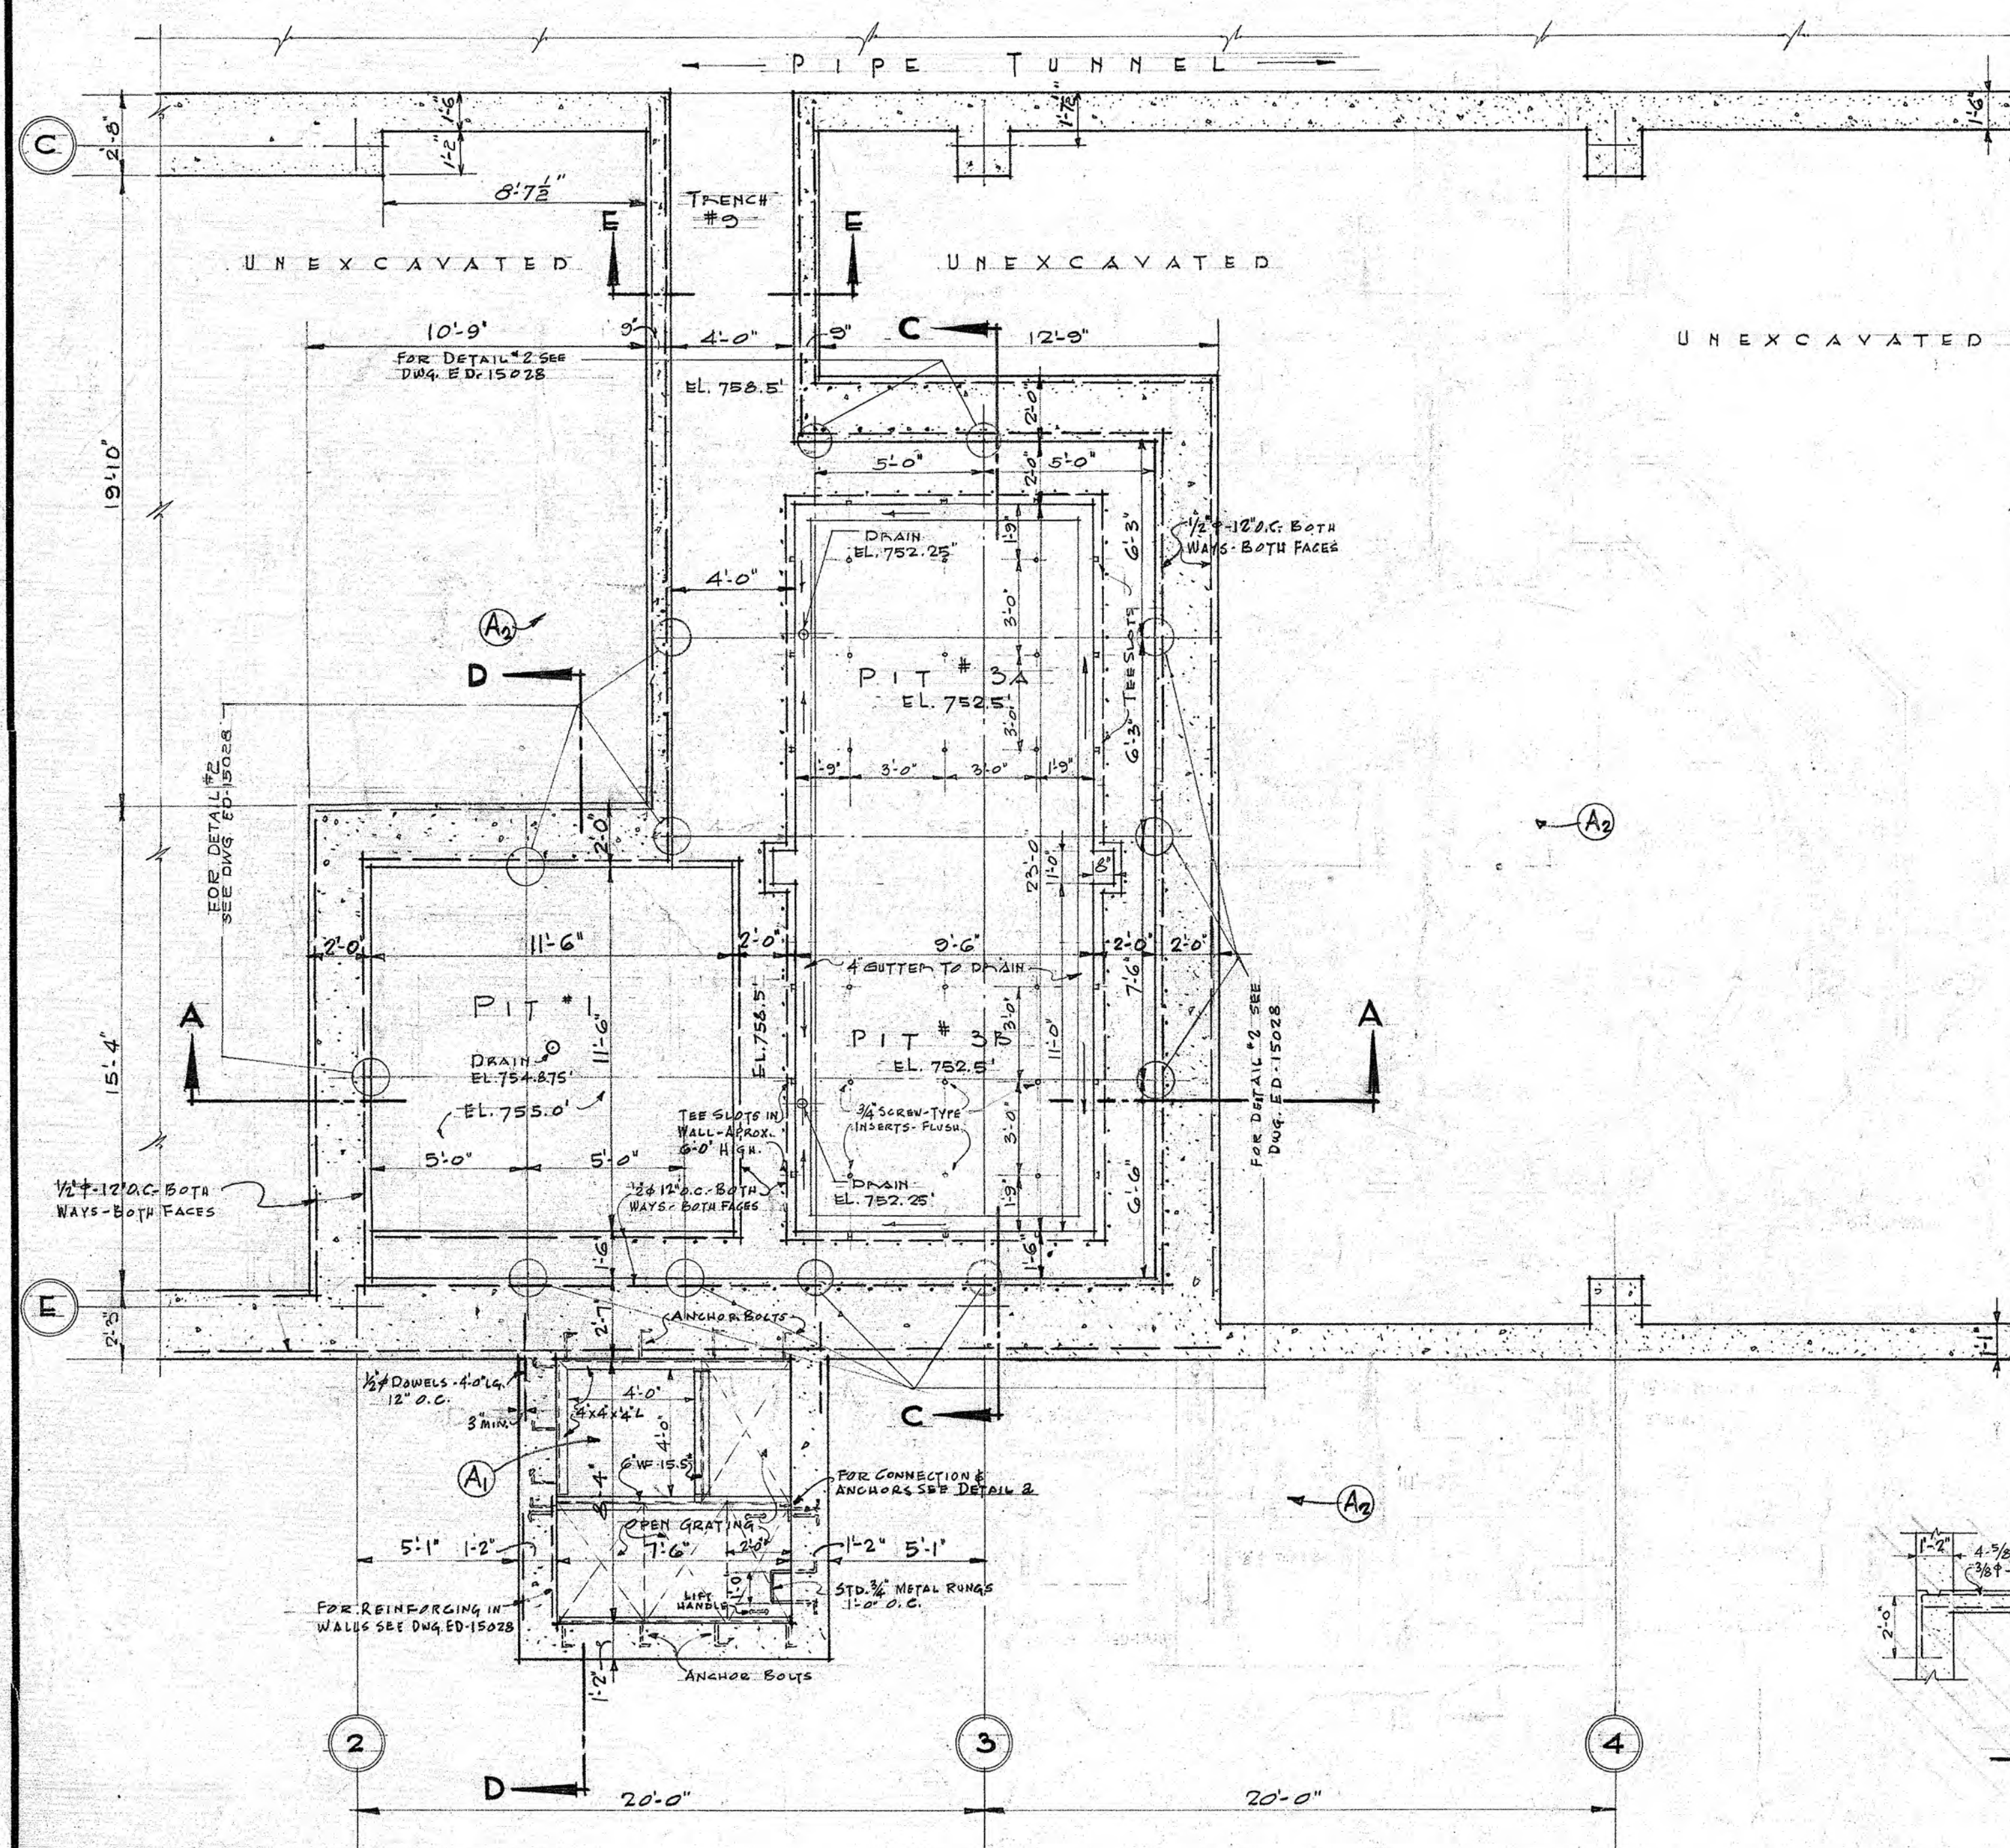


DETAIL PLAN OF SPIN PITS
SCALE 1/4" = 1'-0"

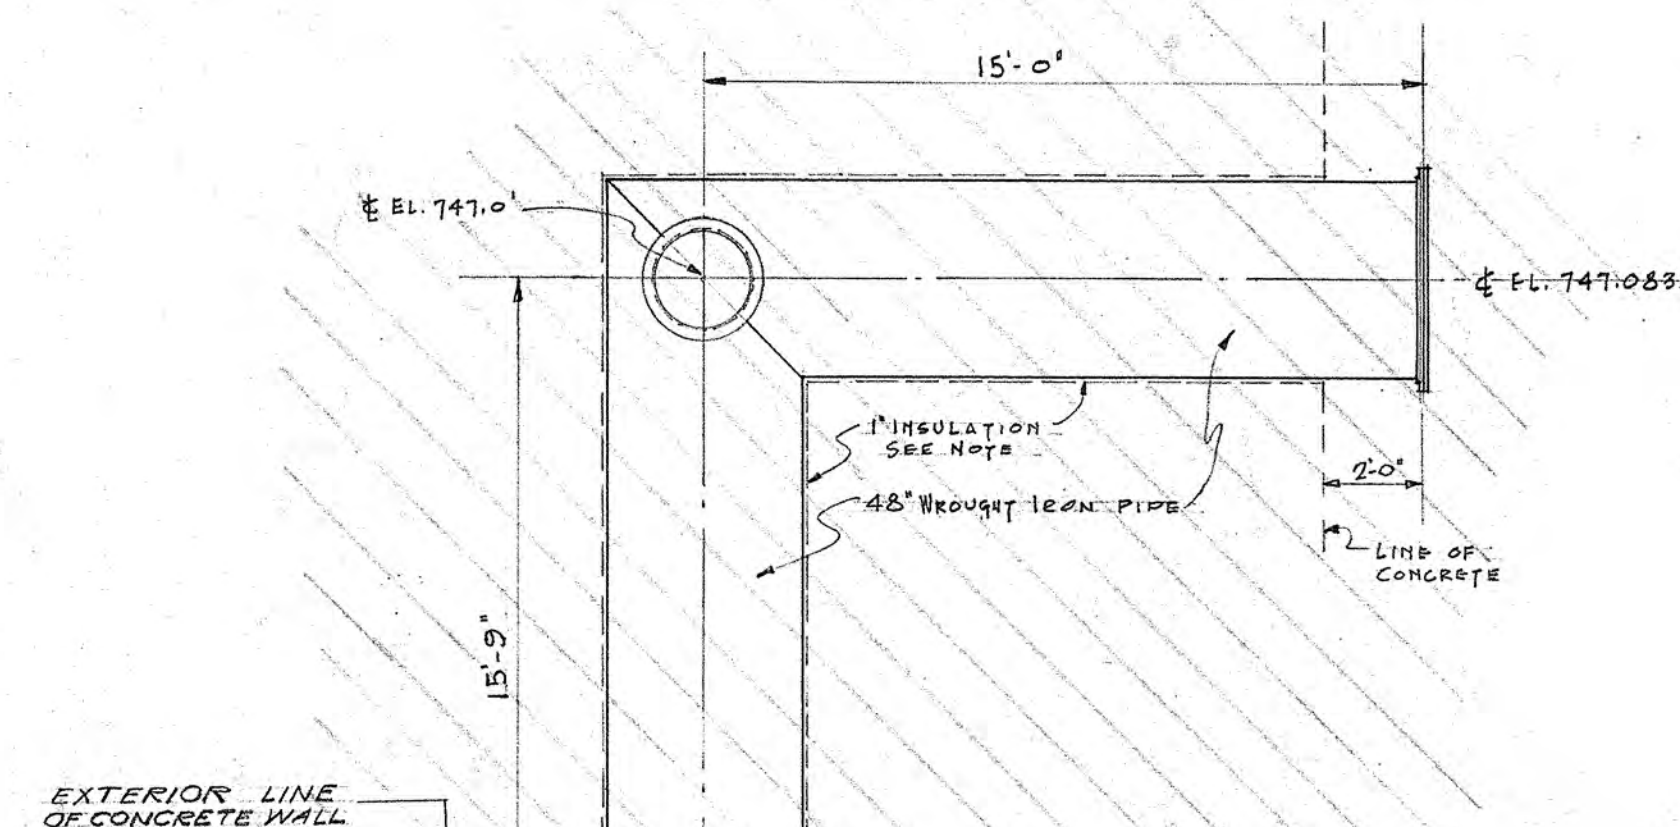


PLAN OF ATMOSPHERIC
EXHAUST PIPE
SCALE 1/4" = 1'-0"

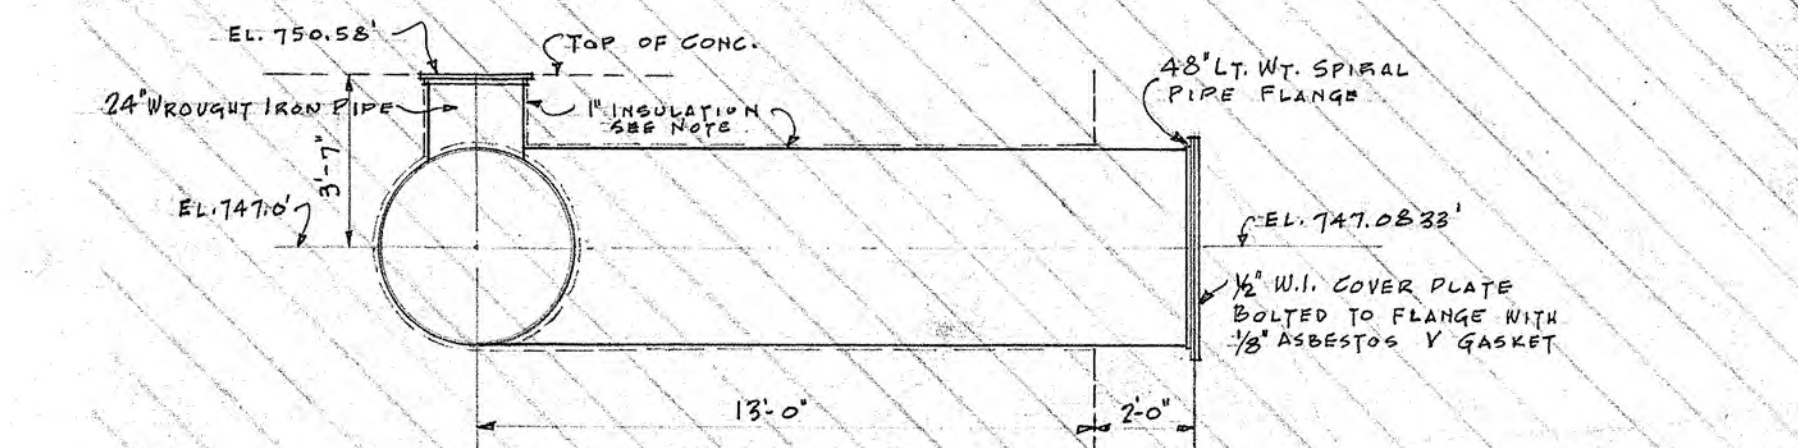


ELEVATION F-F
SCALE 1/4" = 1'-0"

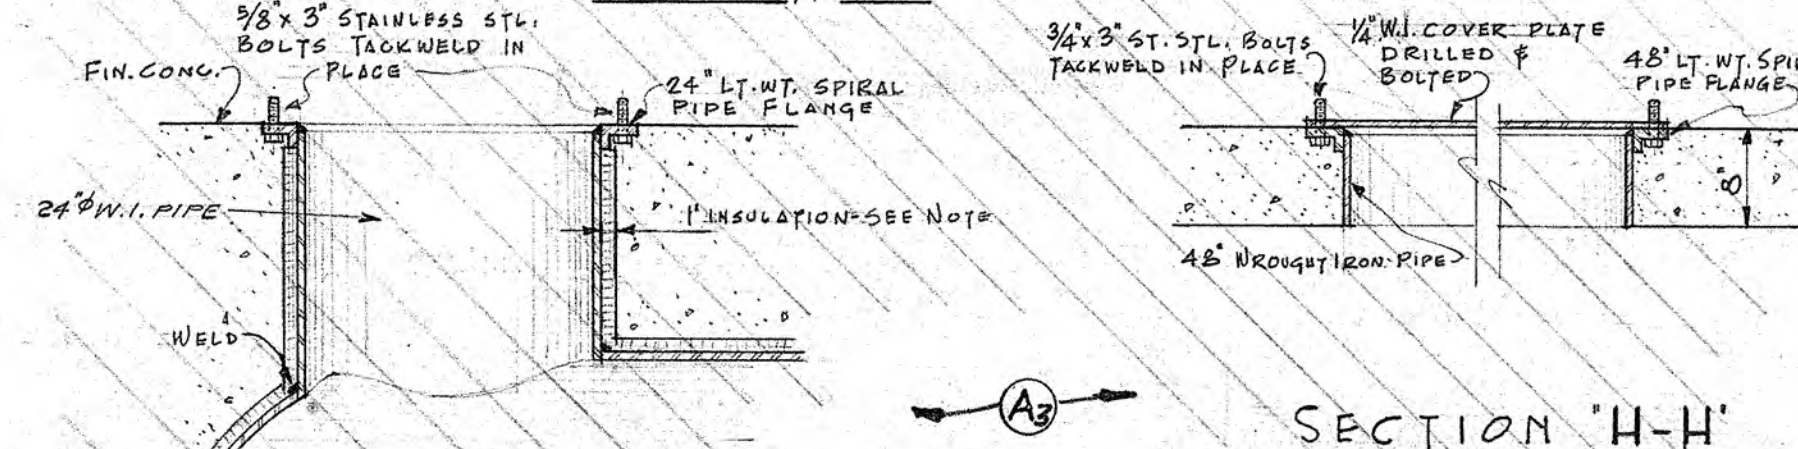


SECTION G-G
SCALE 3/4" = 1'-0"

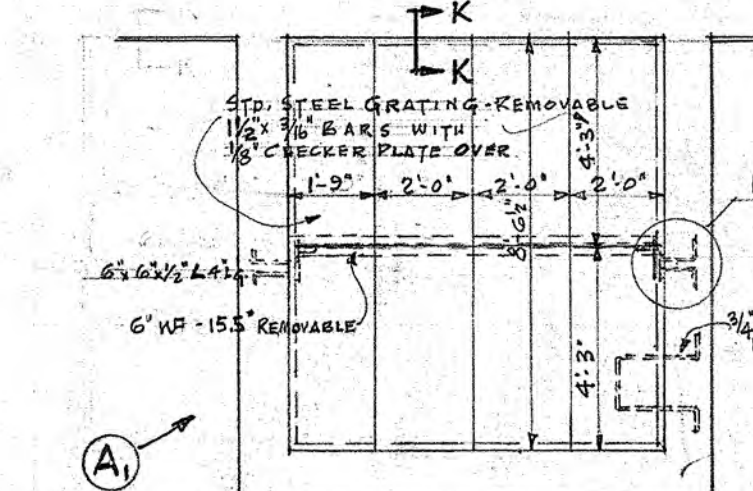


PLAN OF METAL COVERS
ON SUMP PIT'S
SCALE 1/4" = 1'-0"

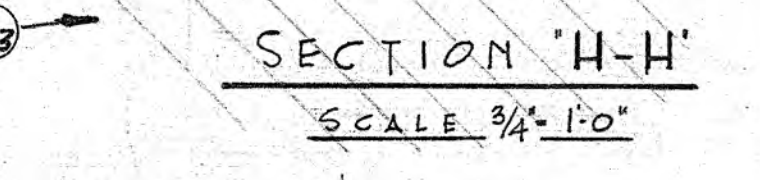

SECTION H-H
SCALE 3/4" = 1'-0"

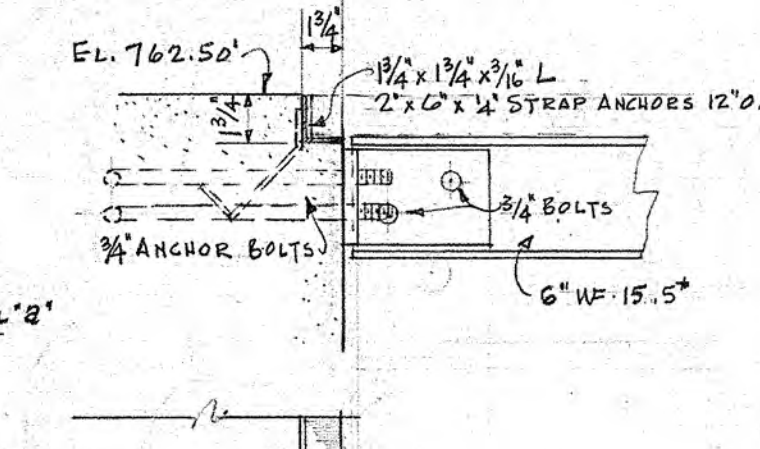

DETAIL 2
SCALE 1 1/2" = 1'-0"

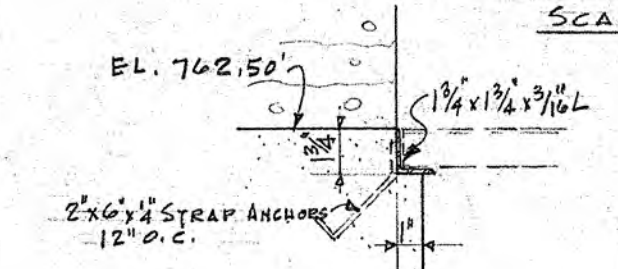


SECTION K-K
SCALE 1 1/2" = 1'-0"

SCALE
AS NOTED

- GENERAL NOTES**
- FOR SECTIONS 'A-A', 'B-B', 'C-C' & 'D-D' SEE SHEET # ED-15028.
 - WHERE SCREW TYPE INSERTS ARE CALLED FOR THEY SHALL BE FLUSH TYPE INSERTS TAPPED FOR 3/4" BOLT SAFE LOAD 1500 LBS/INSERT.


A	1	PLATFORM IN SUMP PIT'S & METAL COVERS REVISED.	DATE	OK APP.
	2	PIT'S 1 & 2 MOVED. PIT'S 3 & 4 REMOVED FROM PLAN.	DATE	OK APP.
	3	SECTIONS 'F-F', 'G-G', 'H-H' & 'J-J' AND PLAN OF ATMOSPHERIC EXHAUST PIPE VOIDED.	DATE	OK APP.
ADDITIONAL JET PROPULSION STATIC TEST LABORATORY				
SPIN PITS #1, 2, 3 & 4 & DETAILS				
NATIONAL ADVISORY COMMITTEE FOR AERONAUTICS AIRCRAFT ENGINE RESEARCH LABORATORY CLEVELAND, OHIO				
JO 10617				ED-15027

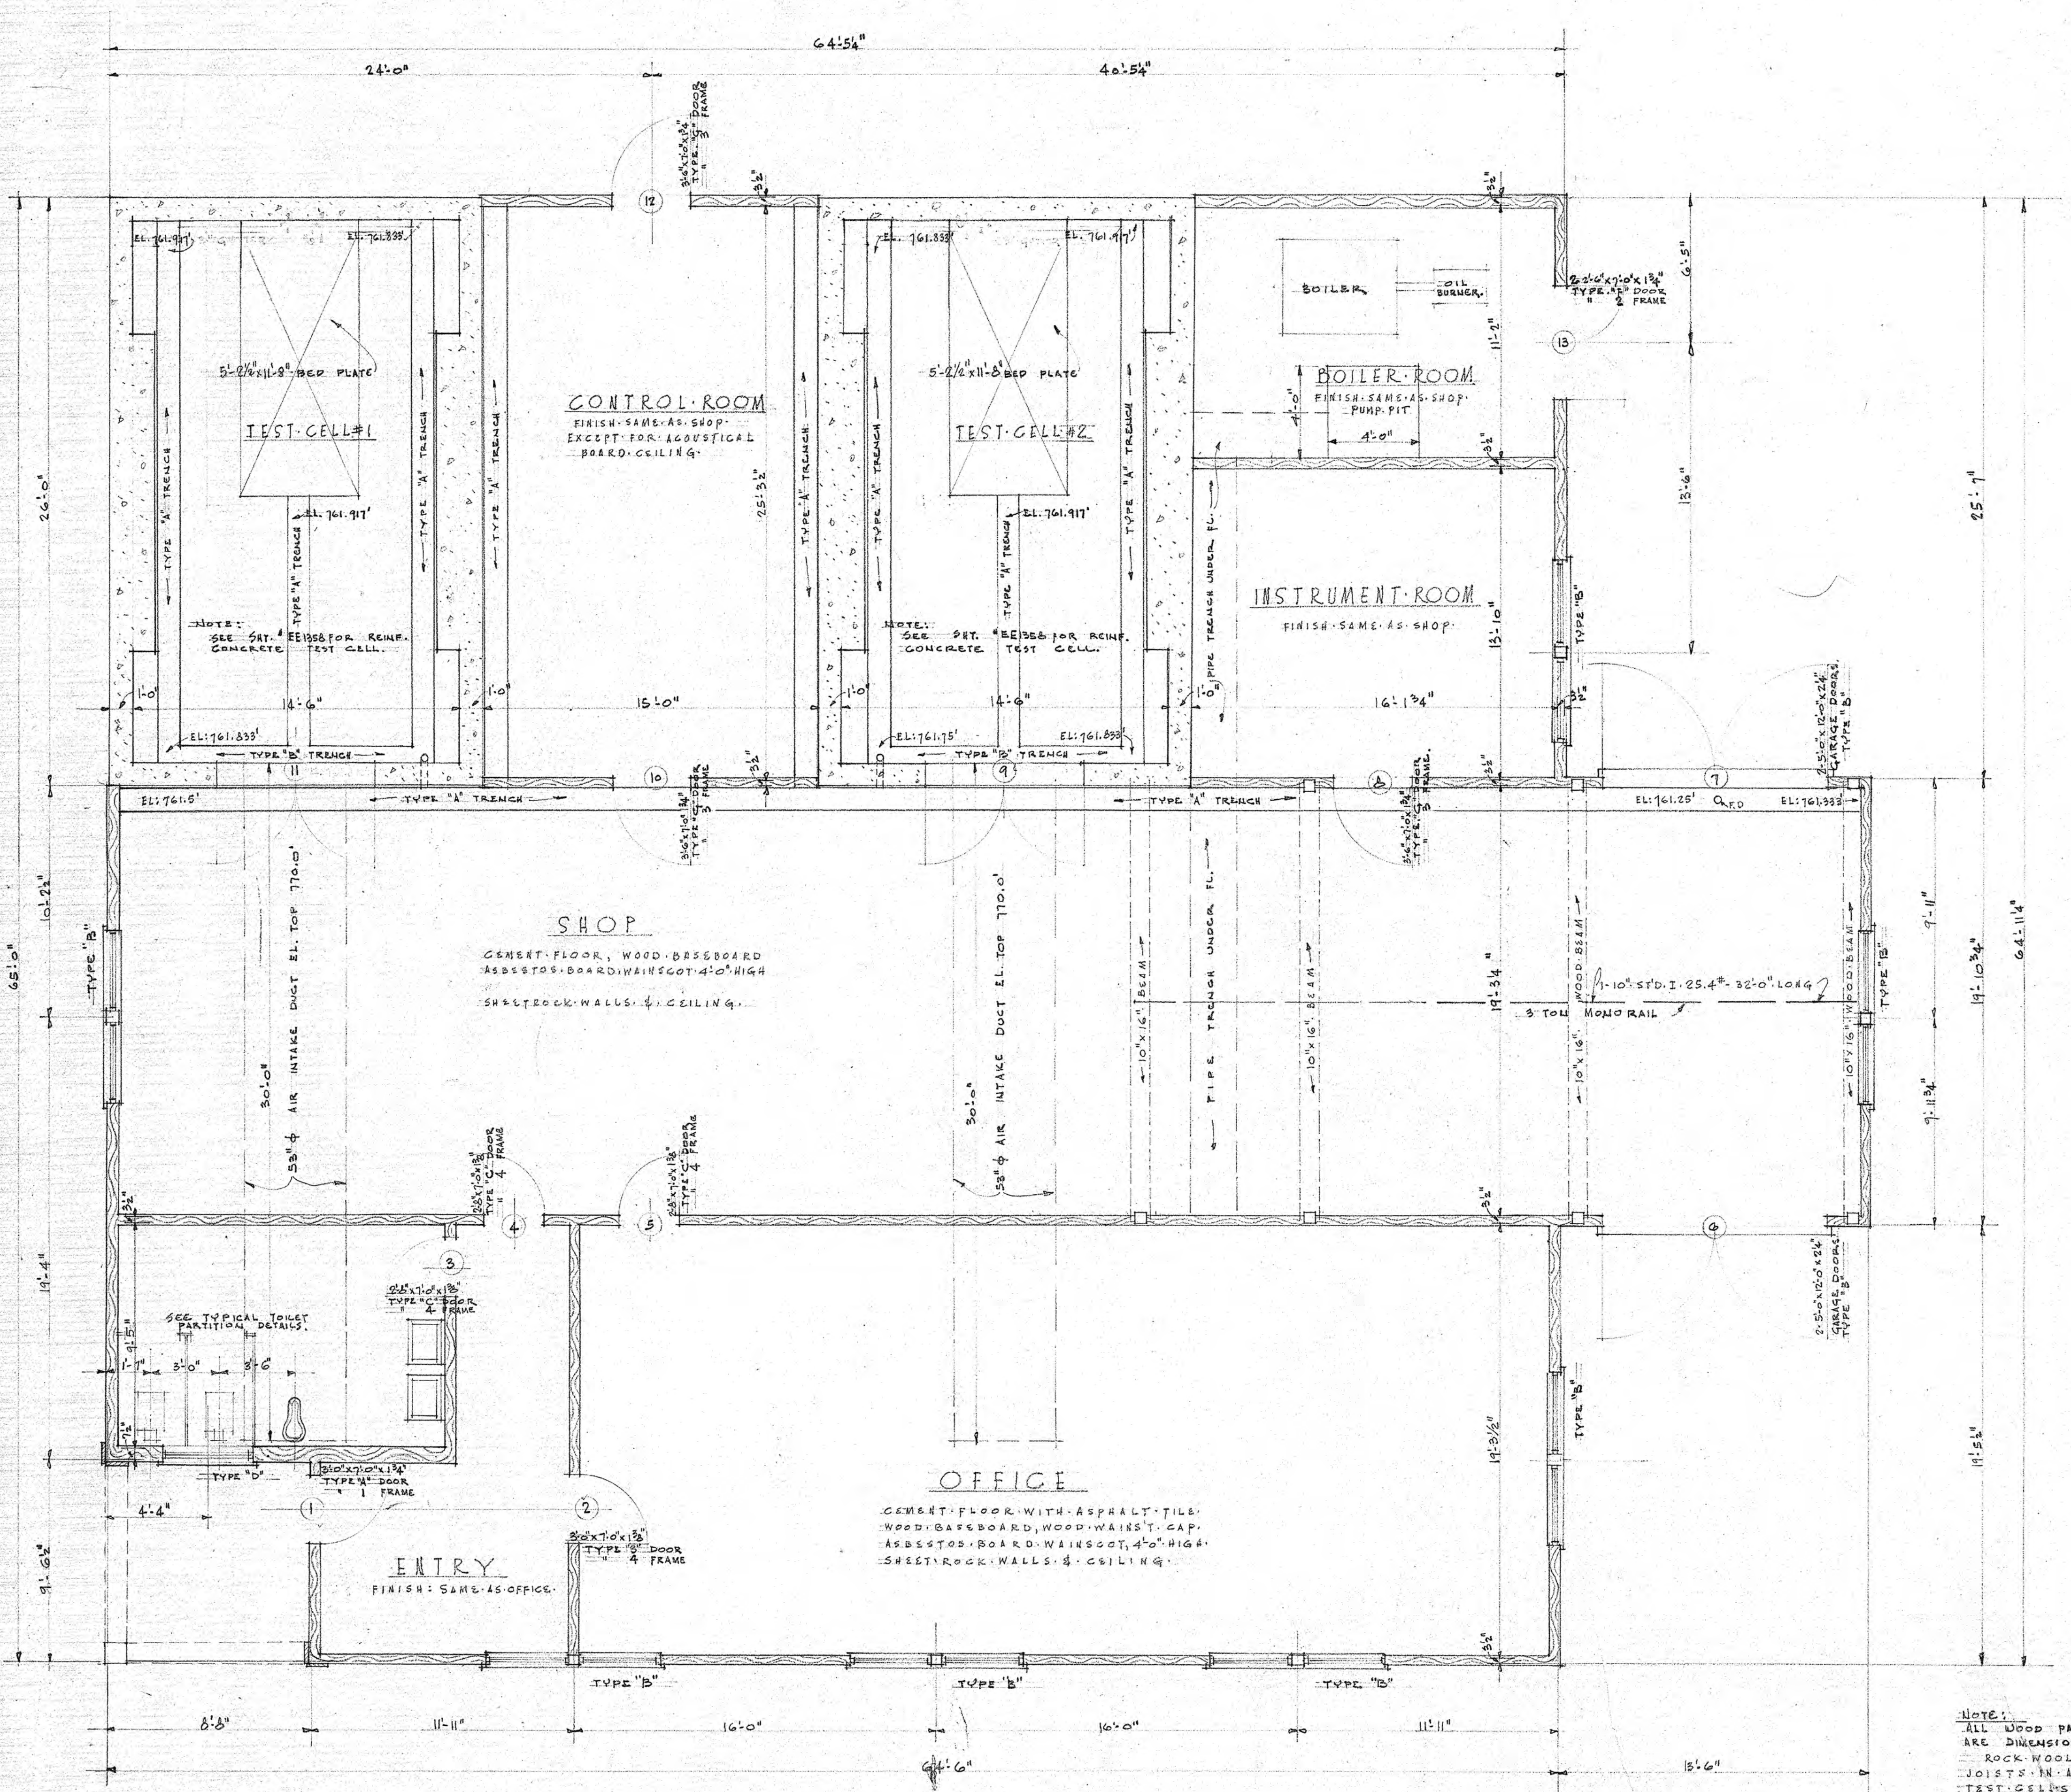


FLOOR PLAN
SCALE 1/4" = 1'-0"


NOTE:
ALL WOOD PART
ARE DIMENSIONED
ROCK WOOL B
JOISTS IN ALL
TEST CELLS
BOILER ROOM

LEGEND:
IN
W

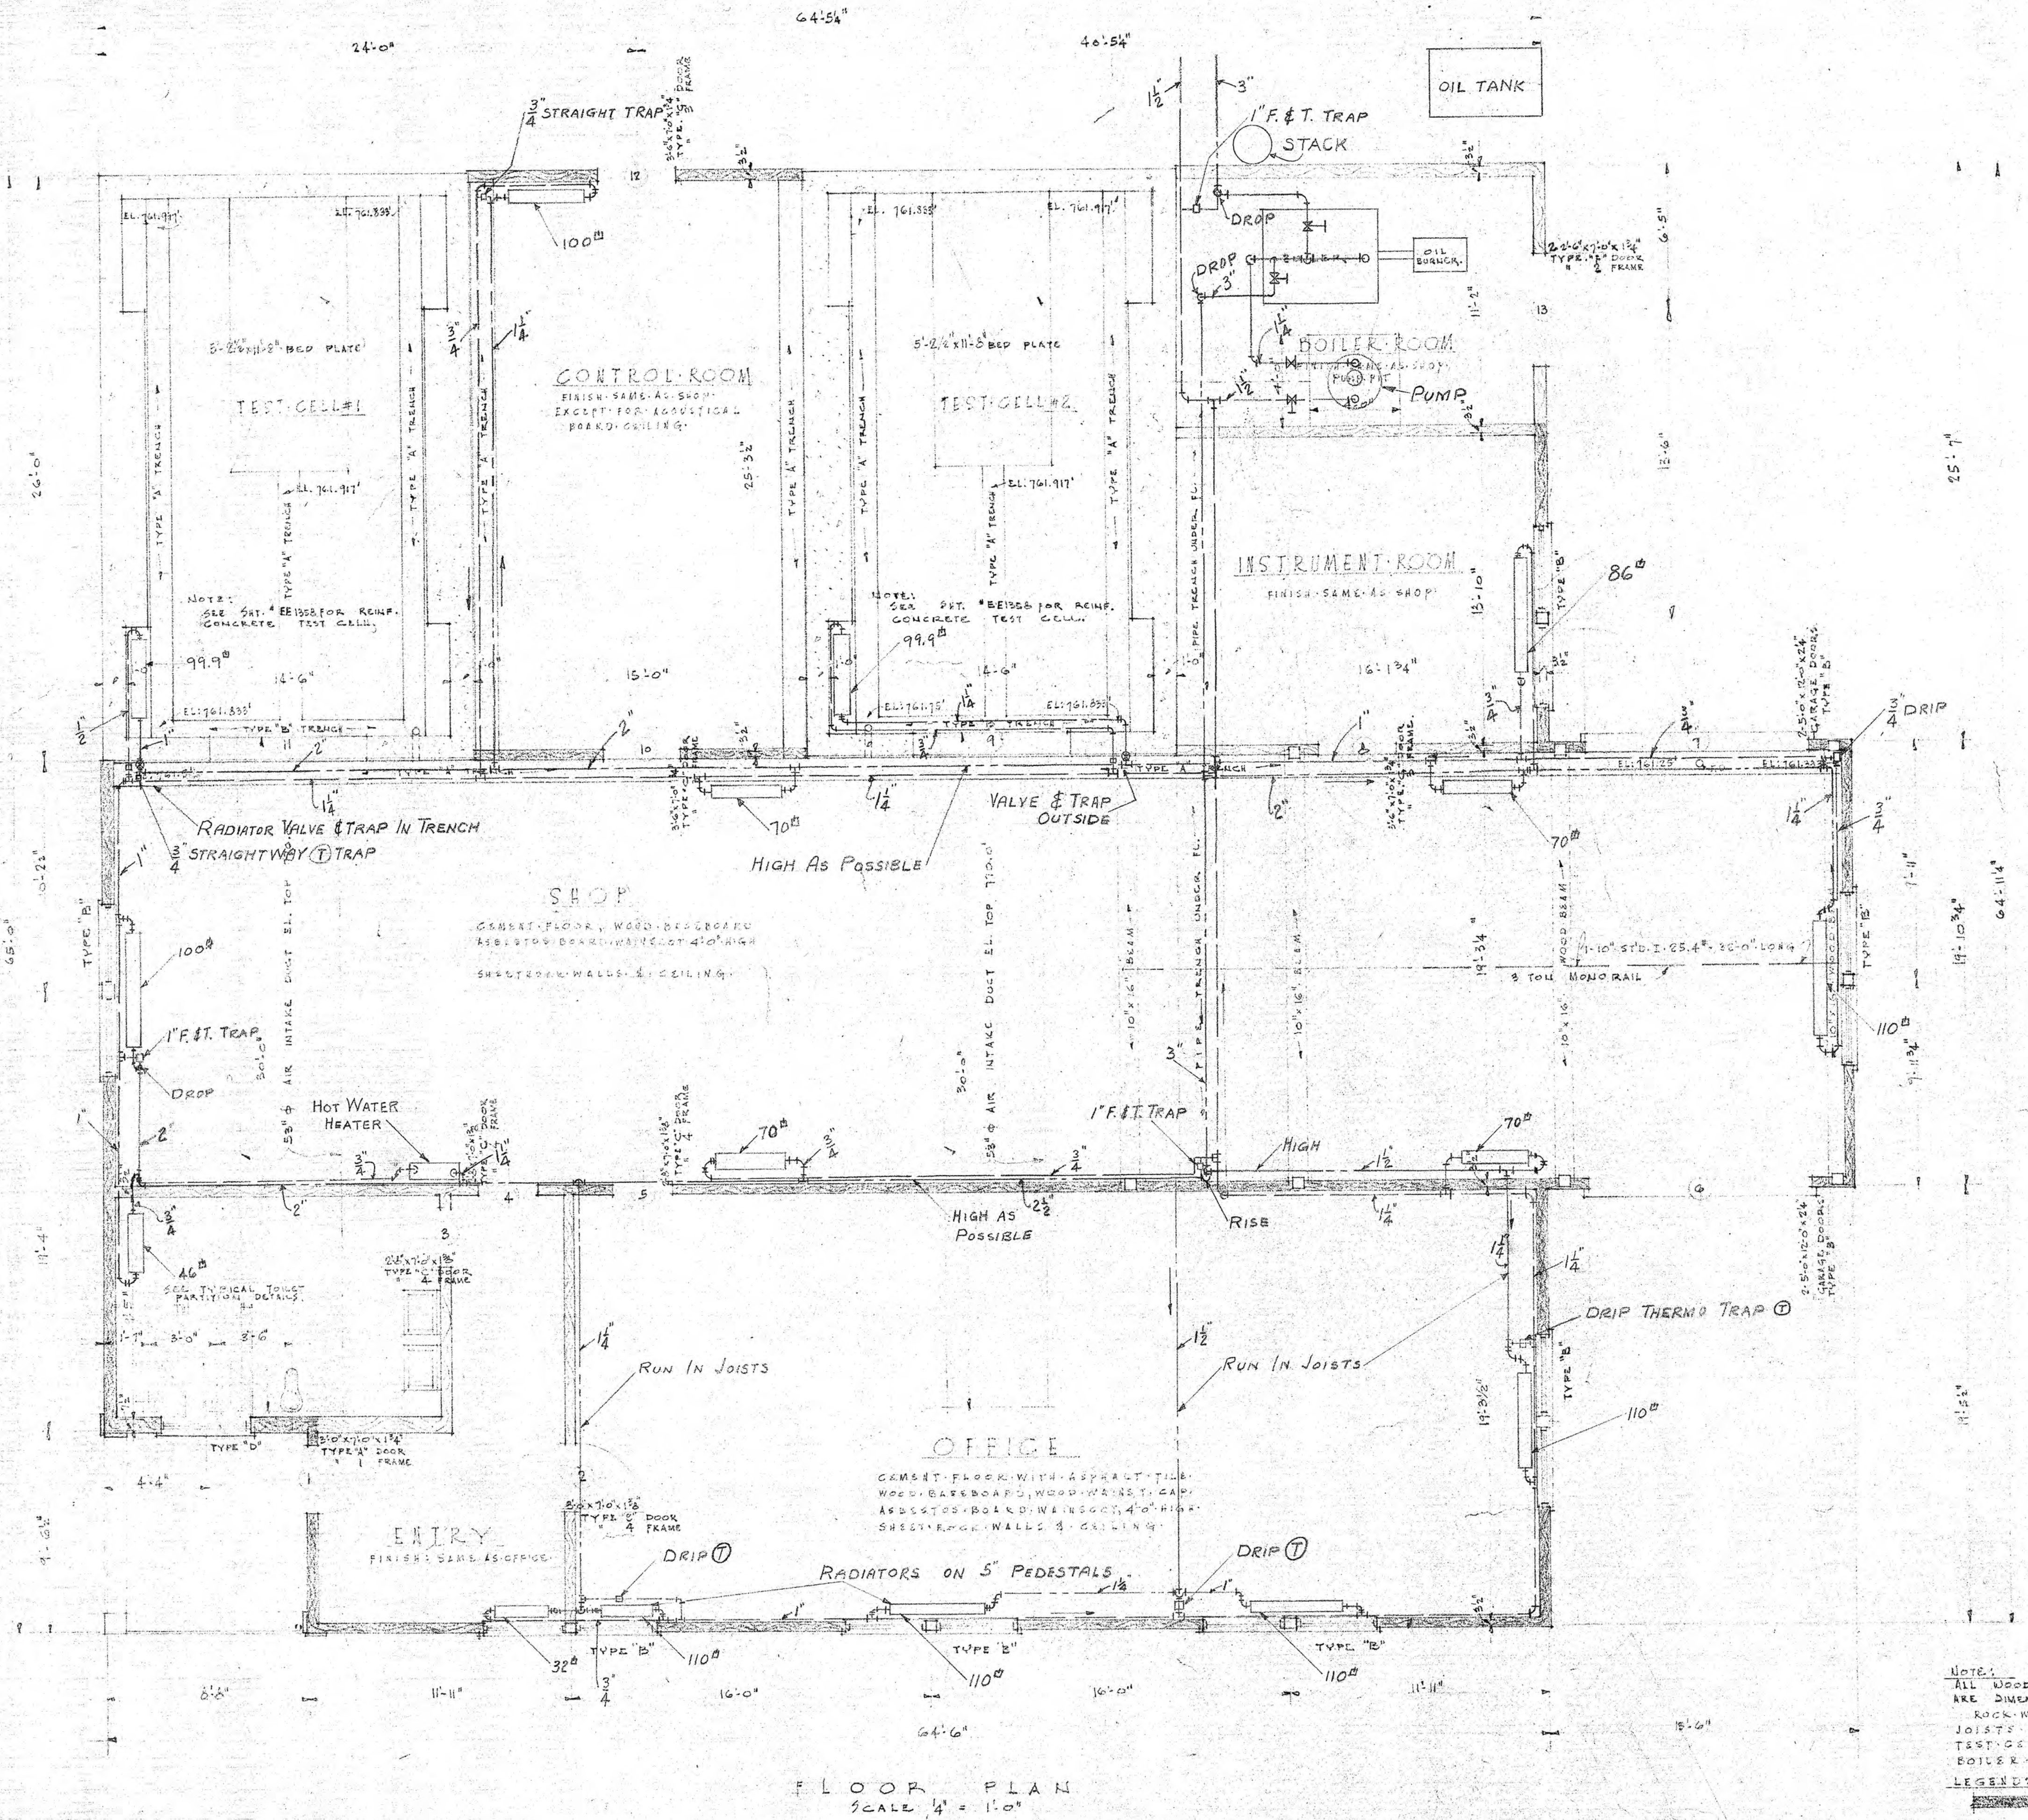

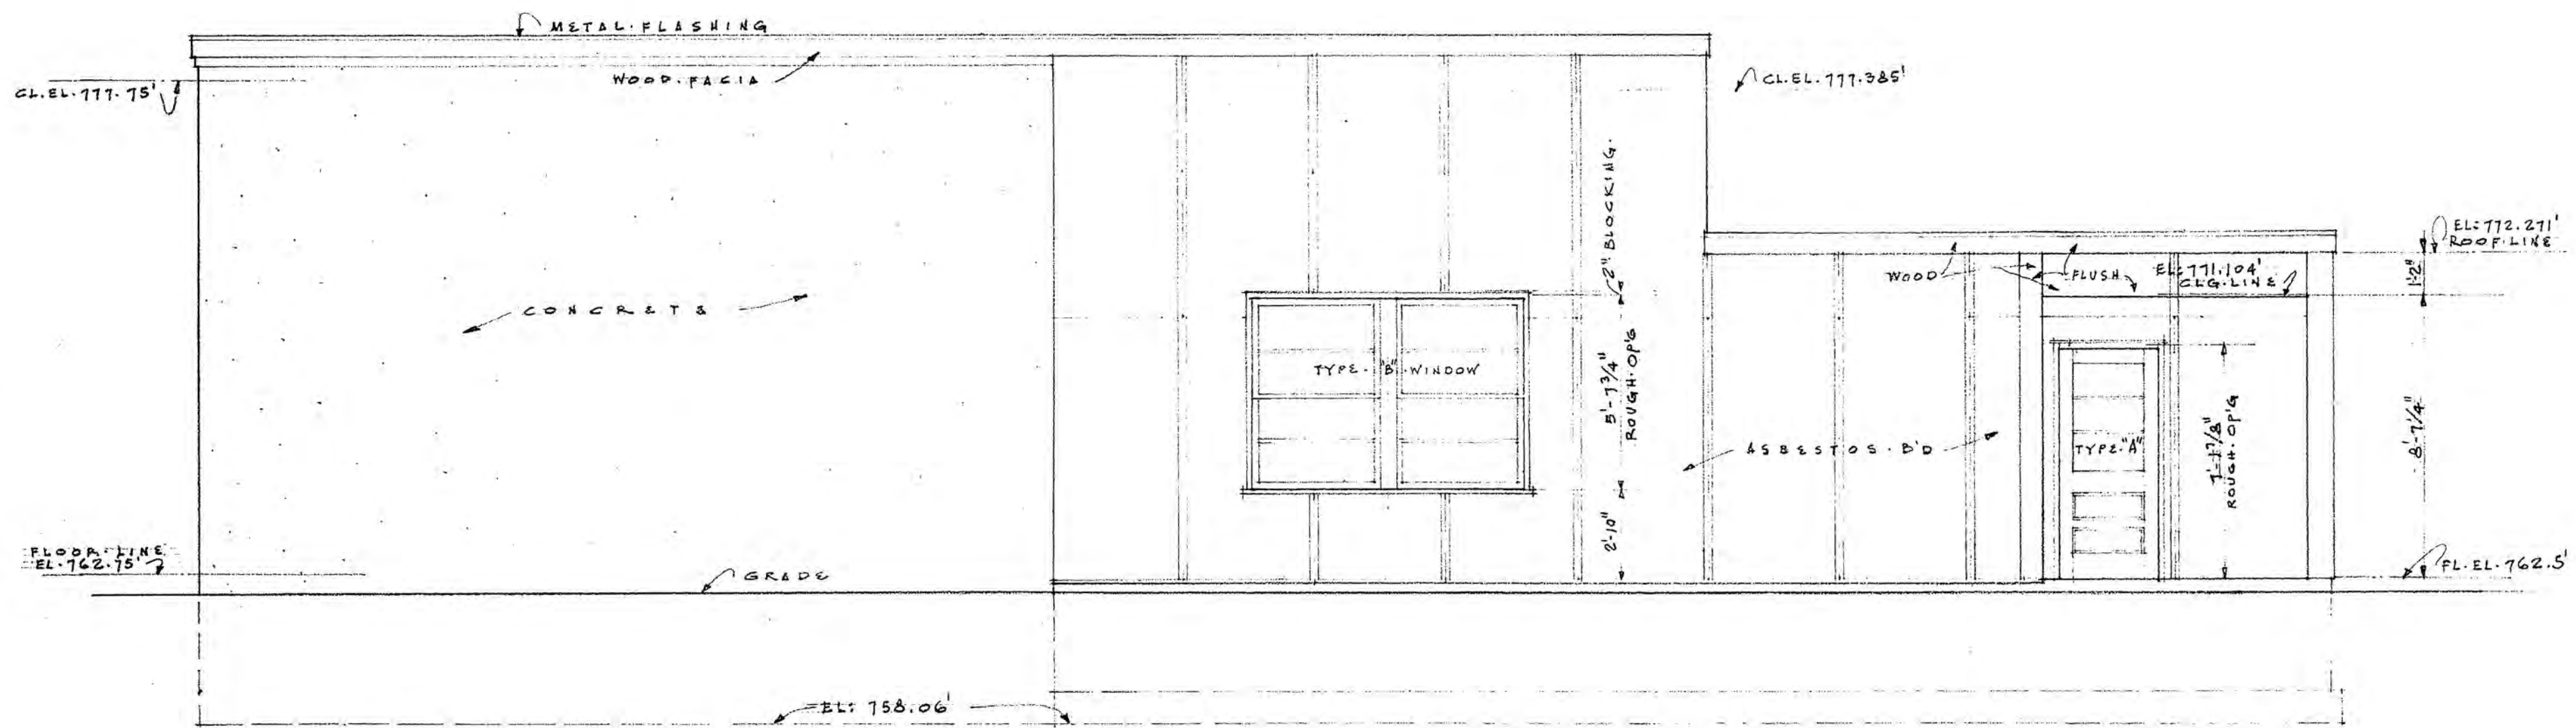

NORTH + ELEVATION
SCALE: 1/4" = 1'-0"

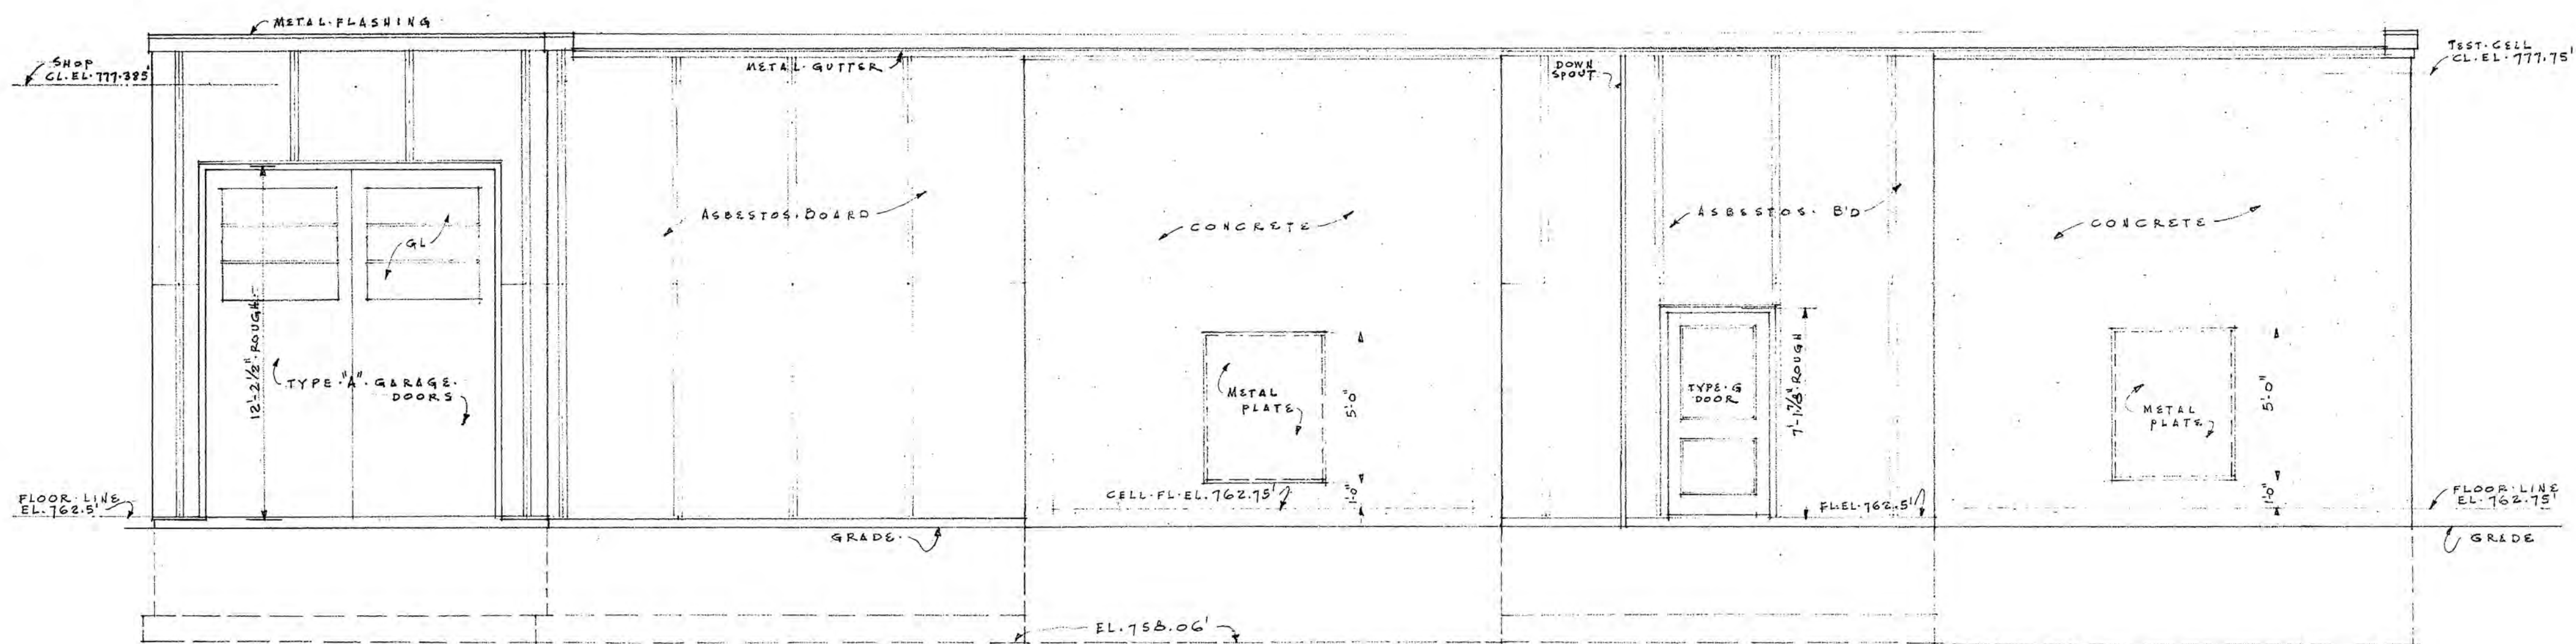

EAST + ELEVATION
SCALE: 1/4" = 1'-0"

